

**ELECTRICAL KEY:**

- ⊕ DUPLEX RECEPTACLE
- ⊖ SPLIT CIRCUIT DUPLEX.
- ⊕ DUPLEX RECEPT, 1/2 SWITCHED
- ⊕<sub>220</sub> 220 VOLT RECEPT.
- ⊕ WP DUPLEX RECEPT. WEATHERPROOF
- ⊕ GFI DUPLEX RECEPTACLE, GROUND FAULT CIRCUIT INTERRUPTER SWITCH

- S<sub>3</sub> SWITCH, THREE-WAY (ETC.)
- CEILING FIXT., SURFACE MOUNT
- <sub>R</sub> CEILING FIXT., RECESSED
- H<sub>D</sub> WALL MOUNTED FIXT.
- FLOURESCENT VALENCE FIXTURE
- FAN

- ⊗ SCD SMOKE / CO DETECTOR
- ⊗ SD SMOKE DETECTOR
- ⊠ DOORBELL PUSH BUTTON
- ⊠ DOORBELL CHIMES
- ◄ TELEPHONE OUTLET

- ⓧ TV TELEVISION OUTLET
- ⓧ<sub>T</sub> ⓧ<sub>H</sub> THERMOSTAT
- ⓧ PC PHOTOCELL
- ▨ ELECTRICAL PANEL
- ⓧ CV CENTRAL VACCUUM


The Manors

BLOCK 5  
RESIDENCE 15



DRAWING TITLE  
BASEMENT FLOOR  
ELECTRICAL LAYOUT

DATE: Jun 21/05  
DWS BY: SEB  
SCALE: 1/4"=1'-0"  
DWS. NO.: R6E

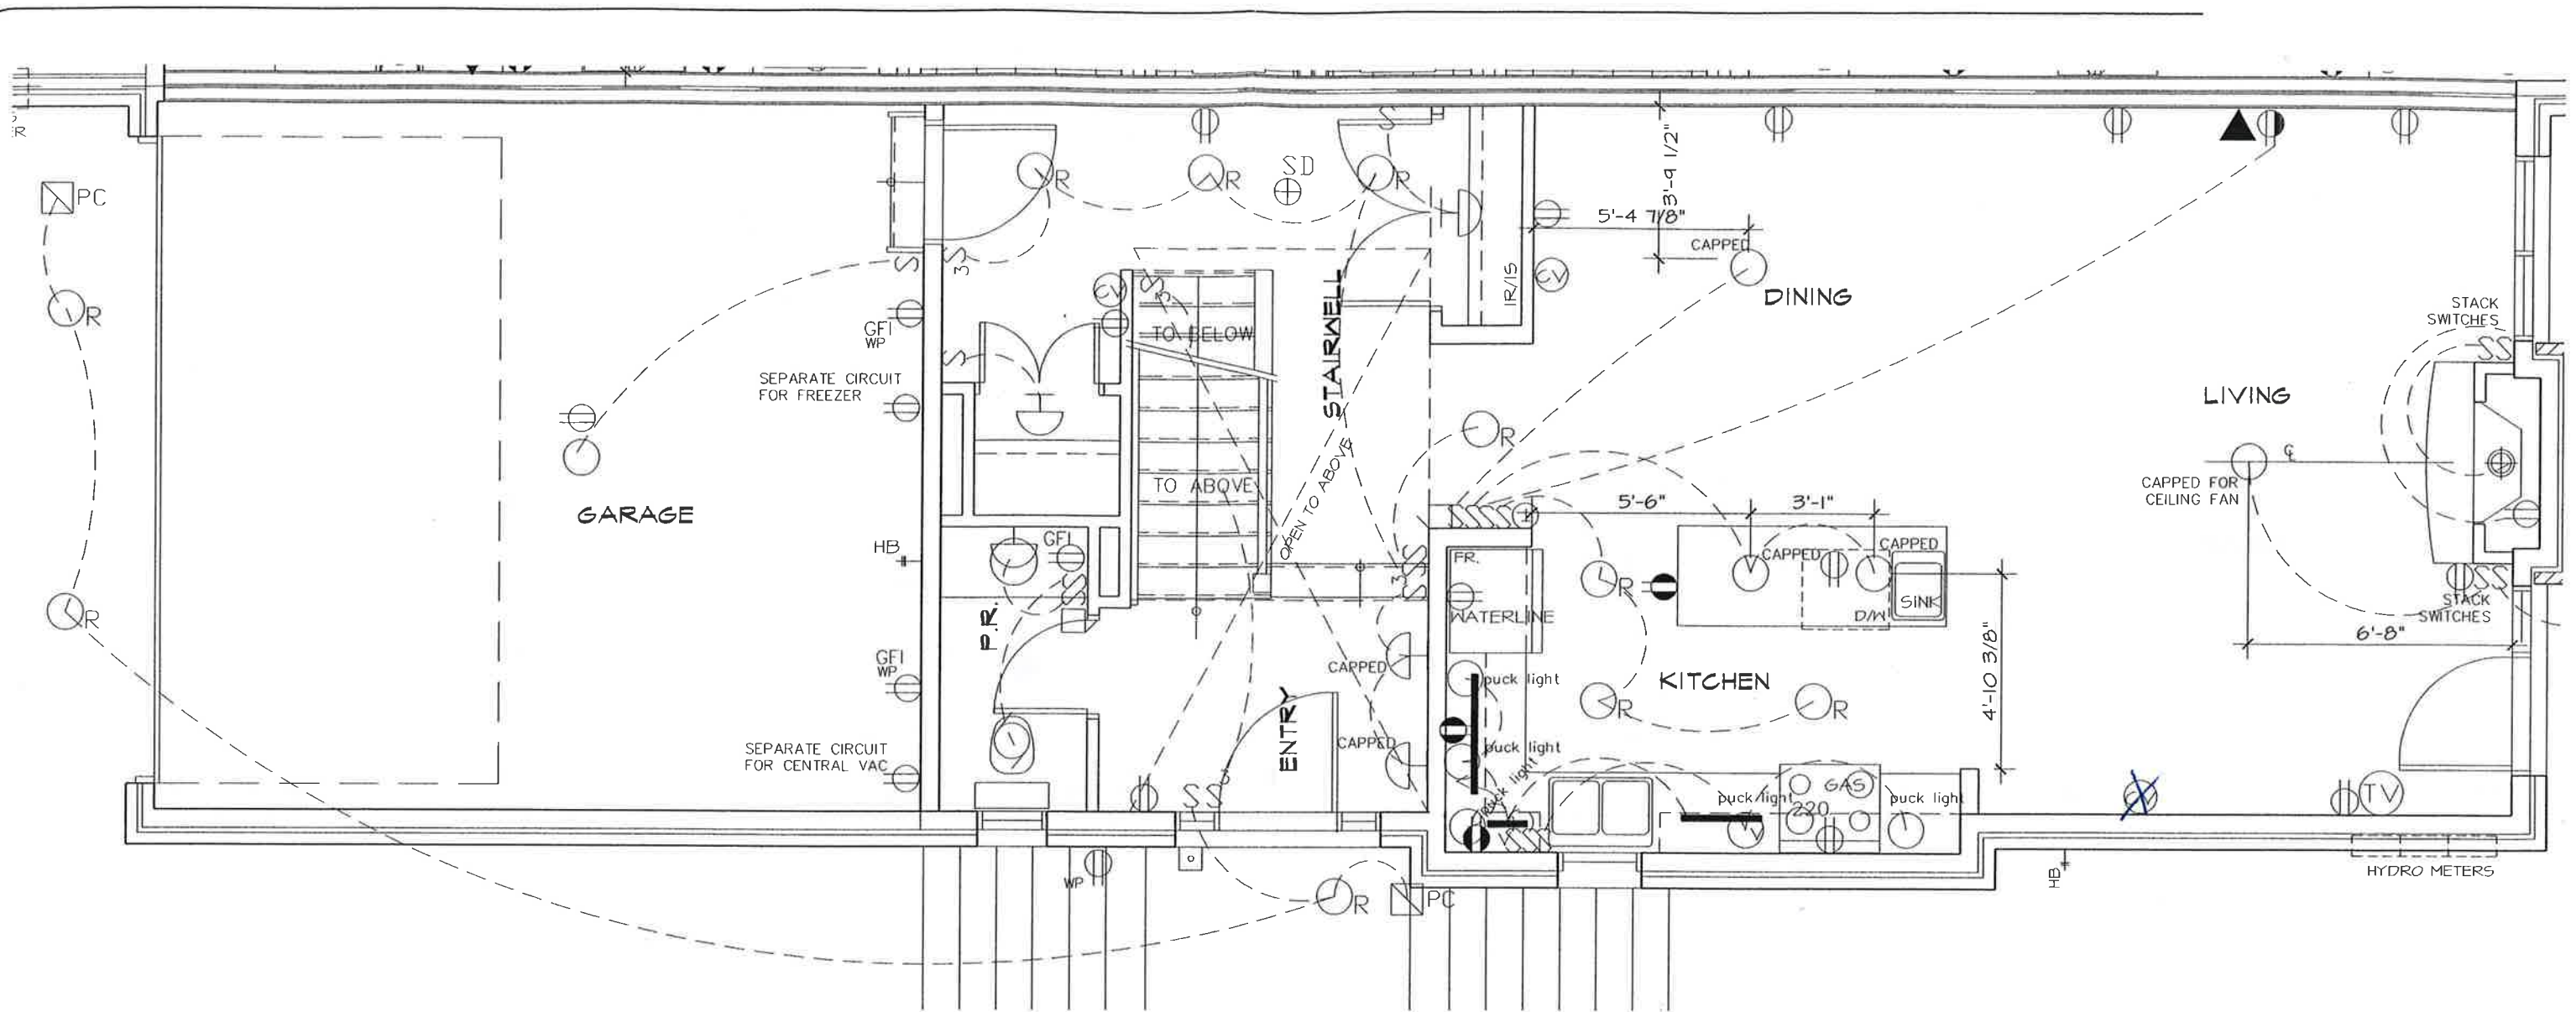

**ELECTRICAL KEY:**

- ⊕ DUPLEX RECEPTACLE
- ⊖ SPLIT CIRCUIT DUPLEX.
- ⊕ DUPLEX RECEPT, 1/2 SWITCHED
- ⊕<sub>220</sub> 220 VOLT RECEPT.
- ⊕<sub>WP</sub> DUPLEX RECEPT. WEATHERPROOF
- ⊕<sub>GFI</sub> DUPLEX RECEPTACLE, GROUND FAULT CIRCUIT INTERRUPTER
- S SWITCH

- S<sub>3</sub> SWITCH, THREE-WAY (ETC.)
- CEILING FIXT., SURFACE MOUNT
- <sub>R</sub> CEILING FIXT., RECESSED
- H<sub>D</sub> WALL MOUNTED FIXT.
- V FLOURESCENT VALENCE FIXTURE
- FAN

- ⊗<sub>SCD</sub> SMOKE / CO DETECTOR
- ⊗<sub>SD</sub> SMOKE DETECTOR
- ⊠ DOORBELL PUSH BUTTON
- ⊠ DOORBELL CHIMES
- ◀ TELEPHONE OUTLET

- ⊕<sub>TV</sub> TELEVISION OUTLET
- ⊕<sub>T</sub> ⊕<sub>H</sub> THERMOSTAT
- ⊠<sub>PC</sub> PHOTOCELL
- ▨ ELECTRICAL PANEL
- ⊕<sub>CV</sub> CENTRAL VACCUM



The Manors

BLOCK 5  
RESIDENCE 15

**UNIFORM**  
Urban Developments  
www.uniformdevelopments.com

DRAWING TITLE  
MAIN FLOOR  
ELECTRICAL LAYOUT

DATE: Jun 21/05  
Dwg BY: SEB  
SCALE: 1/4"=1'-0"  
Dwg. NO: R6-E2

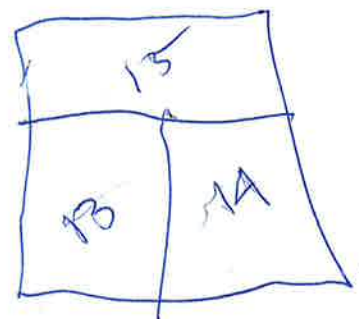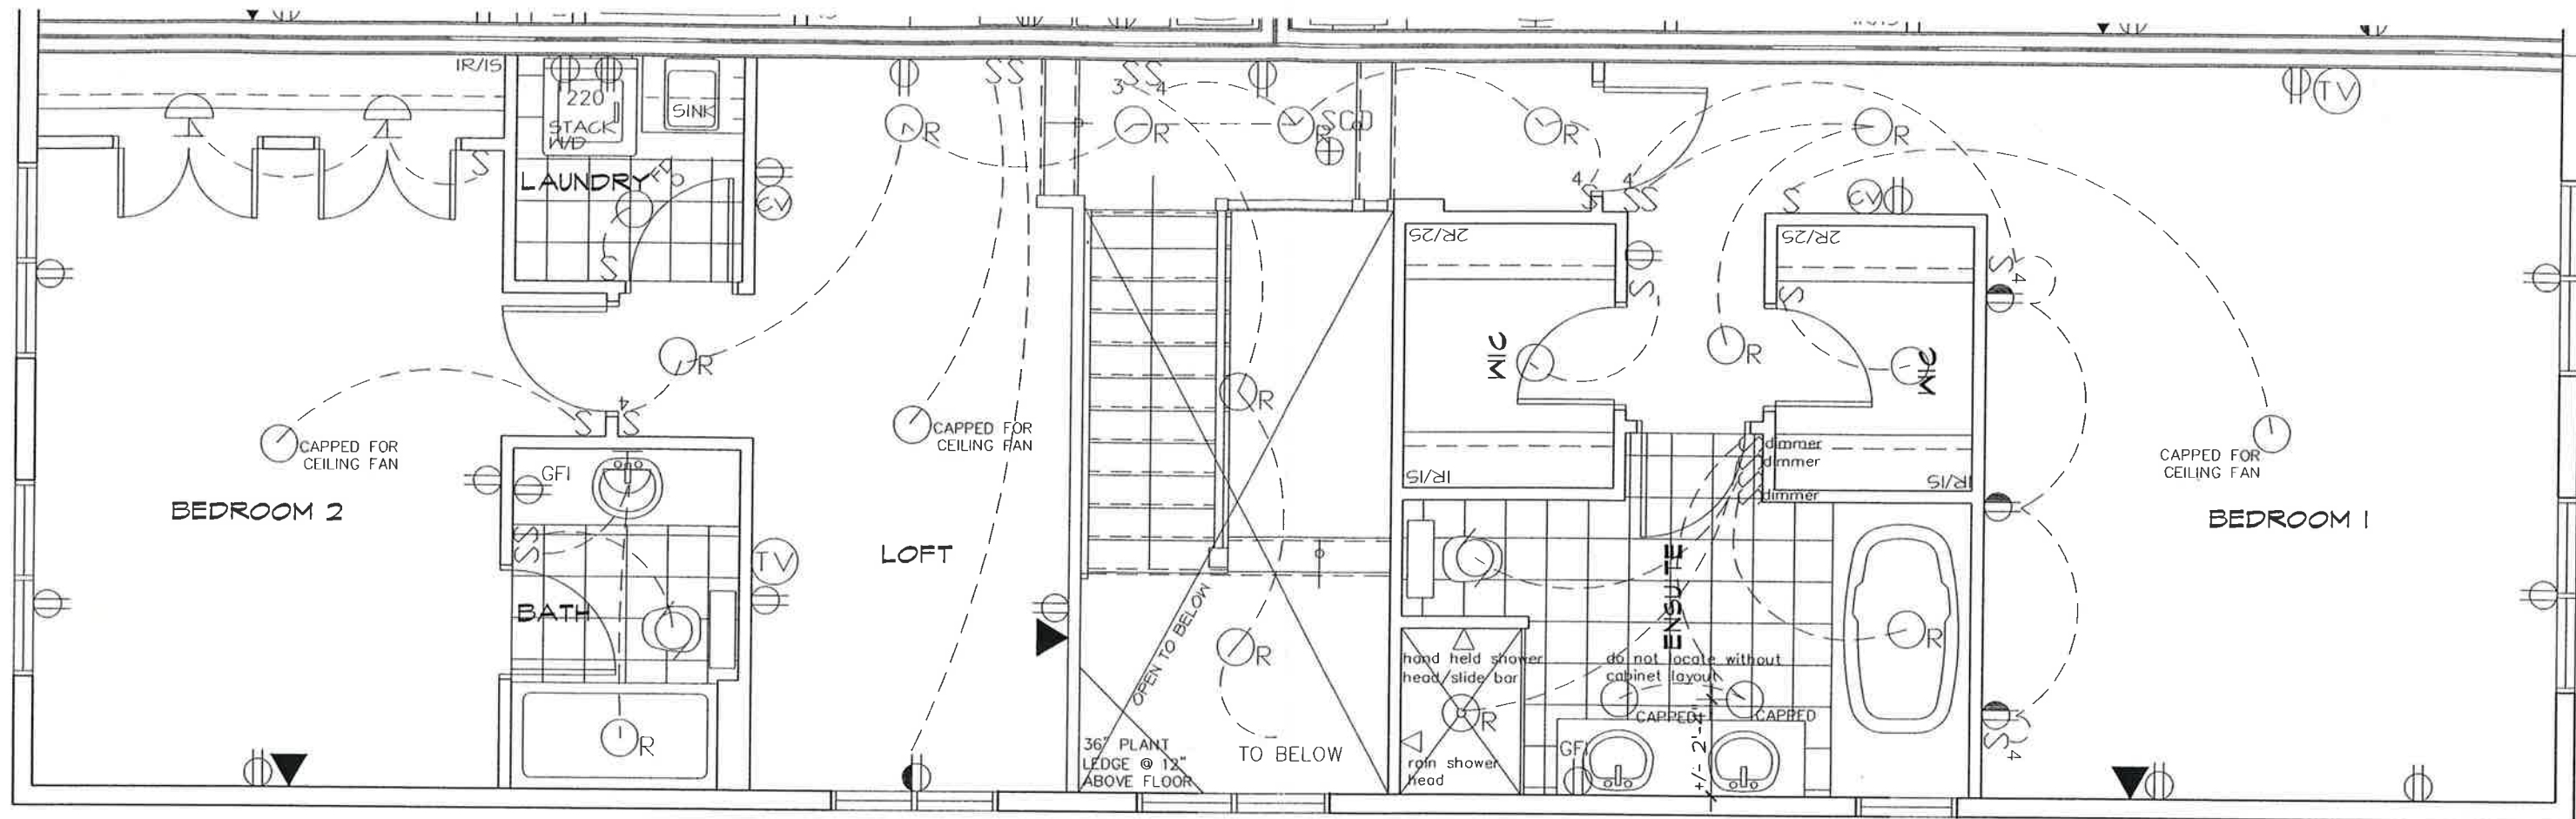

**ELECTRICAL KEY:**

- ⊕ DUPLEX RECEPTACLE
- ⊖ SPLIT CIRCUIT DUPLEX.
- ⊕ DUPLEX RECEPT, 1/2 SWITCHED
- ⊕<sub>220</sub> 220 VOLT RECEPT.
- ⊕<sub>WP</sub> DUPLEX RECEPT. WEATHERPROOF
- ⊕<sub>GFI</sub> DUPLEX RECEPTACLE, GROUND FAULT CIRCUIT INTERRUPTER SWITCH

- S<sub>3</sub> SWITCH, THREE-WAY (ETC.)
- CEILING FIXT., SURFACE MOUNT
- <sub>R</sub> CEILING FIXT., RECESSED
- H<sub>D</sub> WALL MOUNTED FIXT.
- v FLOURESCENT VALENCE FIXTURE
- FAN

- ⊗<sub>SCD</sub> SMOKE / CO DETECTOR
- ⊗<sub>SD</sub> SMOKE DETECTOR
- <sub>DB</sub> DOORBELL PUSH BUTTON
- <sub>DC</sub> DOORBELL CHIMES
- ◀ TELEPHONE OUTLET

- ⊕<sub>TV</sub> TELEVISION OUTLET
- ⊕<sub>T</sub> ⊕<sub>H</sub> THERMOSTAT
- <sub>PC</sub> PHOTOCELL
- ▨ ELECTRICAL PANEL
- ⊕<sub>CV</sub> CENTRAL VACCUUM

The Manors

BLOCK 5  
RESIDENCE 15



DRAWING TITLE  
UPPER FLOOR  
ELECTRICAL LAYOUT

DATE  
Jun 21/05

DWG. NO.  
R6-EB

DWG BY: SEB  
SCALE: 1/4"=1'-0"